

SECOND FLOOR FACILITIES:

ADMINISTRATION OFFICE

- RECEPTION AREA

- MEETING AREA

- PANTRY AREA

- TOILET

-WORK STATIONS (4)

LEGEND:

3.1

WORK STATION

PRINTER

PRINTER

WATER DISPENSER

WATER DISPENSER

STORAGE

STORAGE

INDOOR PLANT

INDOOR PLANT

AC UNIT

AC UNIT

OCCUPIED SPACE


OCCUPIED SPACE

WALL MOUNTED SCREEN

WALL MOUNTED SCREEN

NOTES:

1. ALL DIMENSIONS ARE IN MILLIMETERS.

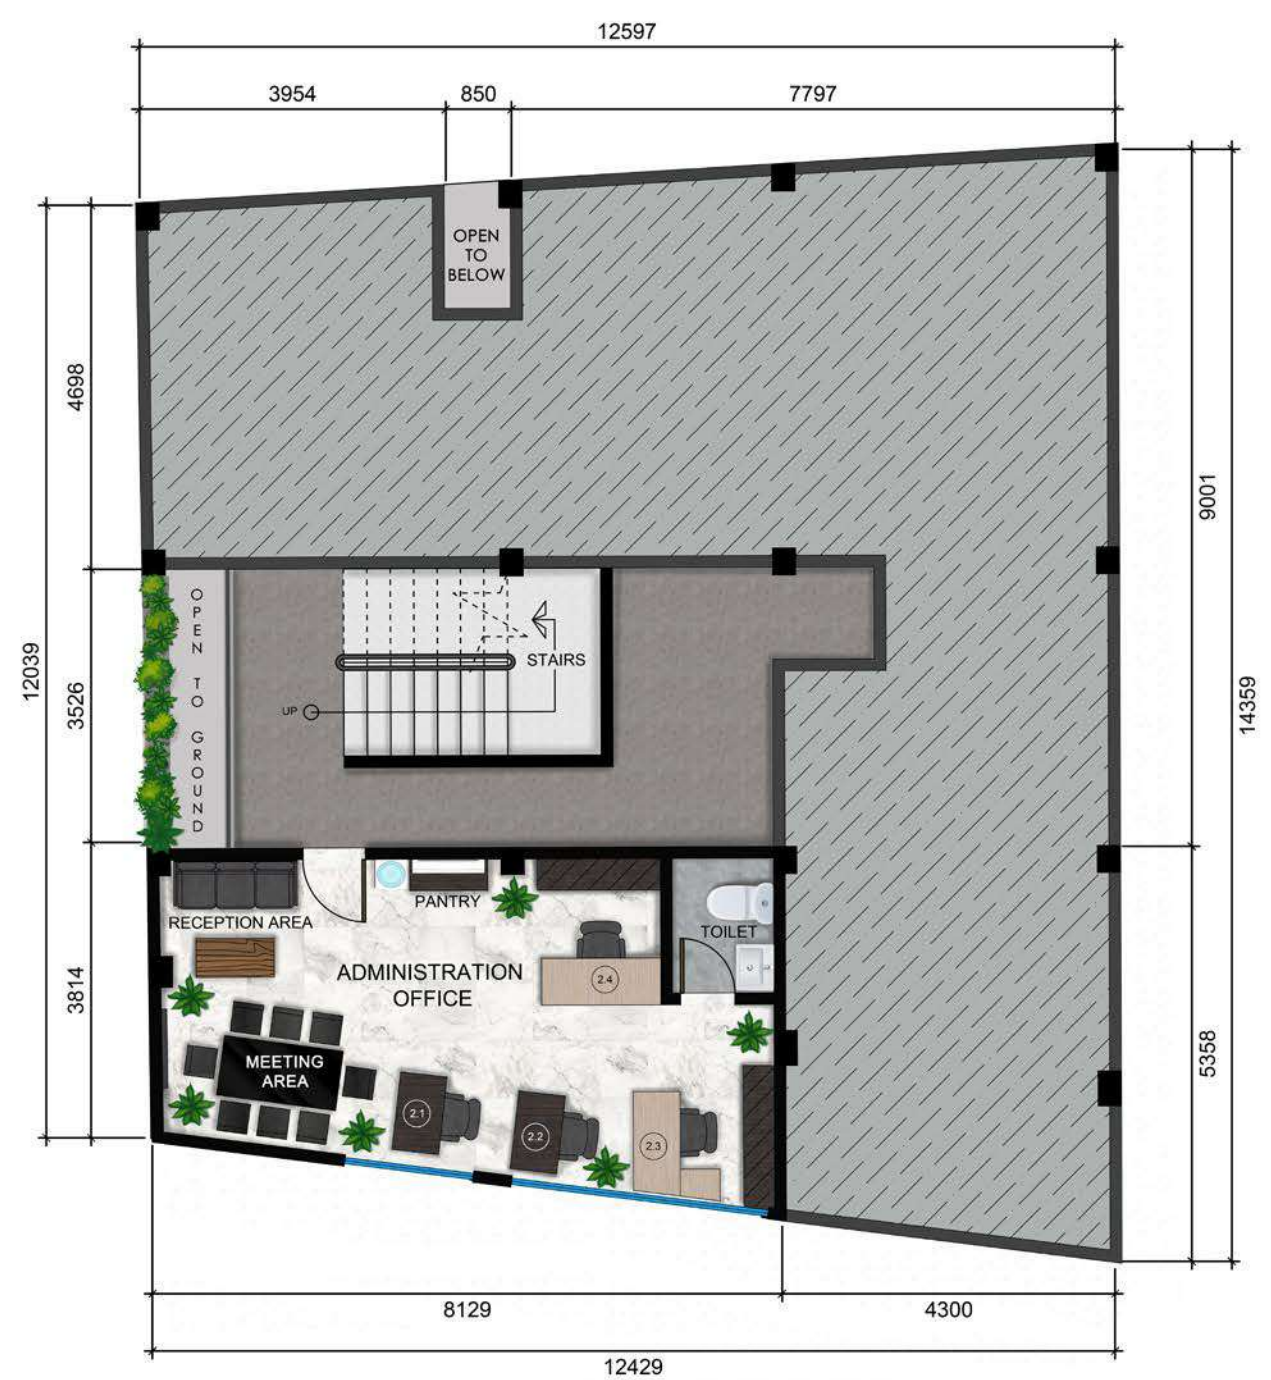

SECOND FLOOR PLAN (OPTION A)

SCALE: 1:100



3D PERSPECTIVE (OPTION A)

 MAGNAPATH AUSTRALIA SRI LANKA PHILIPPINES NEPAL	PROJECT:	SHEET CONTENT:	DESIGN BY:	CADD BY:
	BPO/KPO OFFICE SPACE LARGE TEAM ENVIRONMENT	SECOND FLOOR PLAN	NCP	NCP
		3D PERSPECTIVE	CHECKED BY:	
			AOM	
	LOCATION:		APPROVED BY:	DATE:
	GMC BUILDING, JP LAUREL HIGHWAY, TANUAN CITY, PHILIPPINES 4232		GN	10/29/2019
			SHEET NO:	REVISION:
		SCALE: 1:100	PL01	V5

THIRD FLOOR FACILITIES:

BPO/KPO OFFICE

- RECEPTION AREA

- MEETING AREA

- PANTRY AREA

- SERVER ROOM

- TOILETS (5)

- WORK STATIONS (59)

LEGEND:

3.1

WORK STATION

PRINTER

WATER DISPENSER

STORAGE

INDOOR PLANT

AC UNIT

I.T. FACILITIES

- MULTIPLE 100 mbps CONNECTION AVAILABLE.

- SERVER OPTION AVAILABLE.

- DESKTOP PCs (8 GB RAM, 120 GB SSD).

- I.T SUPPORT STAFF.

NOTES:

1. ALL DIMENSIONS ARE IN MILLIMETERS.



2. TEAM CONFIGURATION IS AN SUGGETED EXAMPLE ONLY.

3. MEETING/ CONFERENCE ROOM AVAILABLE IN SECOND FLOOR.



THIRD FLOOR PLAN (OPTION A)

SCALE: 1:100

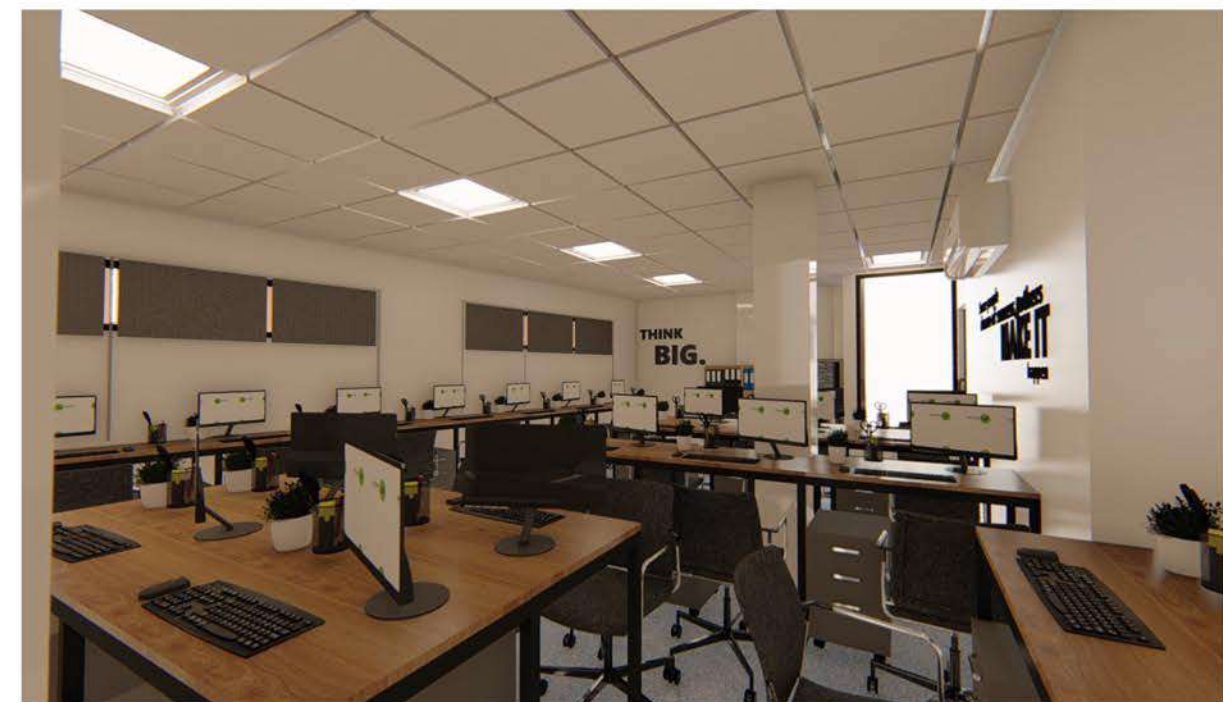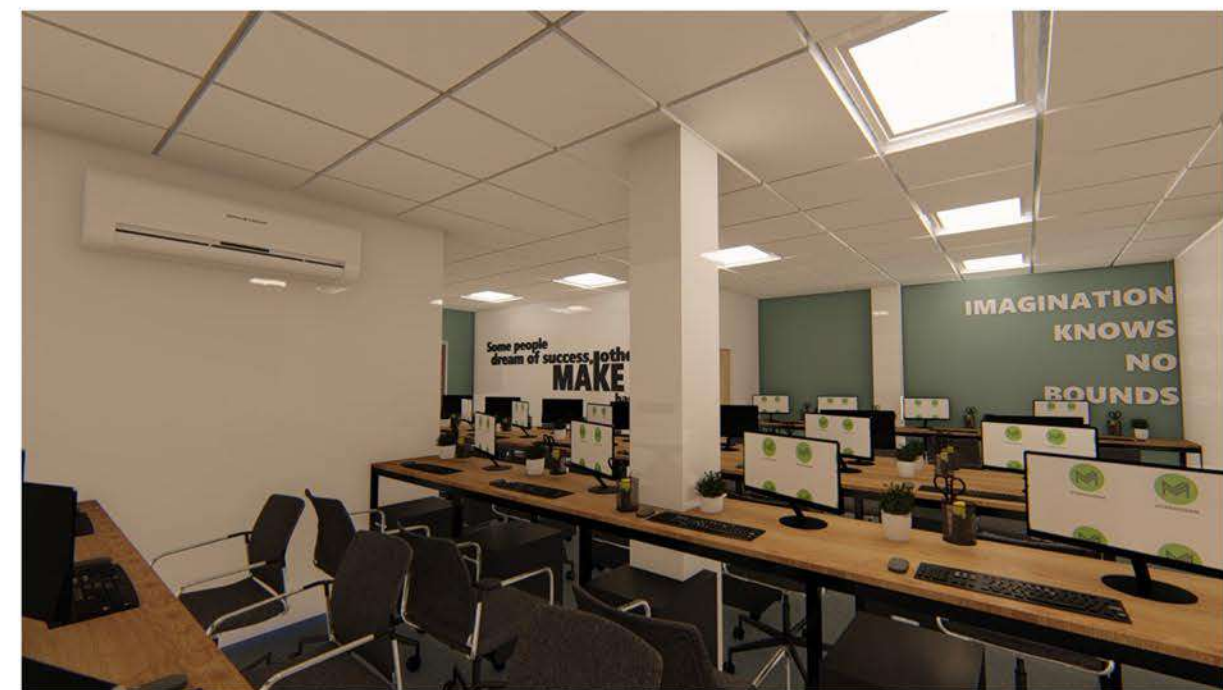

3D PERSPECTIVE (OPTION A)

SCALE: NTS

 MAGNAPATH AUSTRALIA SRI LANKA PHILIPPINES NEPAL	PROJECT:	BPO/KPO OFFICE SPACE (OPTION A) LARGE TEAM ENVIRONMENT	SHEET CONTENT:	DESIGN BY:	CADD BY:
	LOCATION:		THIRD FLOOR PLAN	NCP	NCP
			3D PERSPECTIVE	CHECKED BY:	
				AOM	
			APPROVED BY:	DATE:	
	GMC BUILDING, JP LAUREL HIGHWAY, TANUAN CITY, PHILIPPINES 4232		GN	10/29/209	
				SHEET NO:	REVISION:
			SCALE: 1:100	PL04	V5

FOURTH FLOOR FACILITIES:

BPO/KPO OFFICE

- RECEPTION AREA

- MEETING AREA

- PANTRY AREA

- SERVER ROOM

- TOILETS (4)

- WORK STATIONS (52)

LEGEND:

3.1

WORK STATION

PRINTER

WATER DISPENSER

STORAGE

INDOOR PLANT

AC UNIT

I.T FACILITIES

MULTIPLE 100 mbps CONNECTION AVAILABLE.

SERVER OPTION AVAILABLE.

DESKTOP PCs (8 GB RAM, 120 GB SSD).

I.T SUPPORT STAFF.

NOTES:



1. ALL DIMENSIONS ARE IN MILLIMETERS.

2. TEAM CONFIGURATION IS AN SUGGETED EXAMPLE ONLY.

3. MEETING/ CONFERENCE ROOM AVAILABLE IN SECOND FLOOR.



FOURTH FLOOR PLAN (OPTION A)
SCALE: 1:100

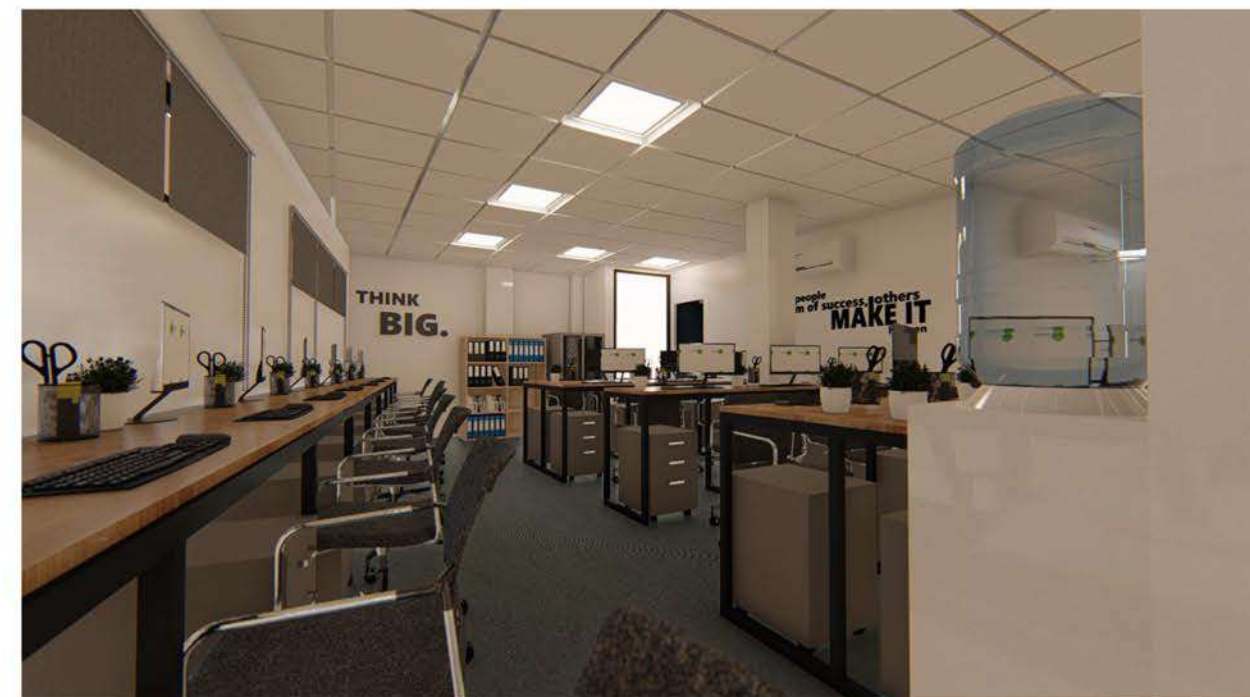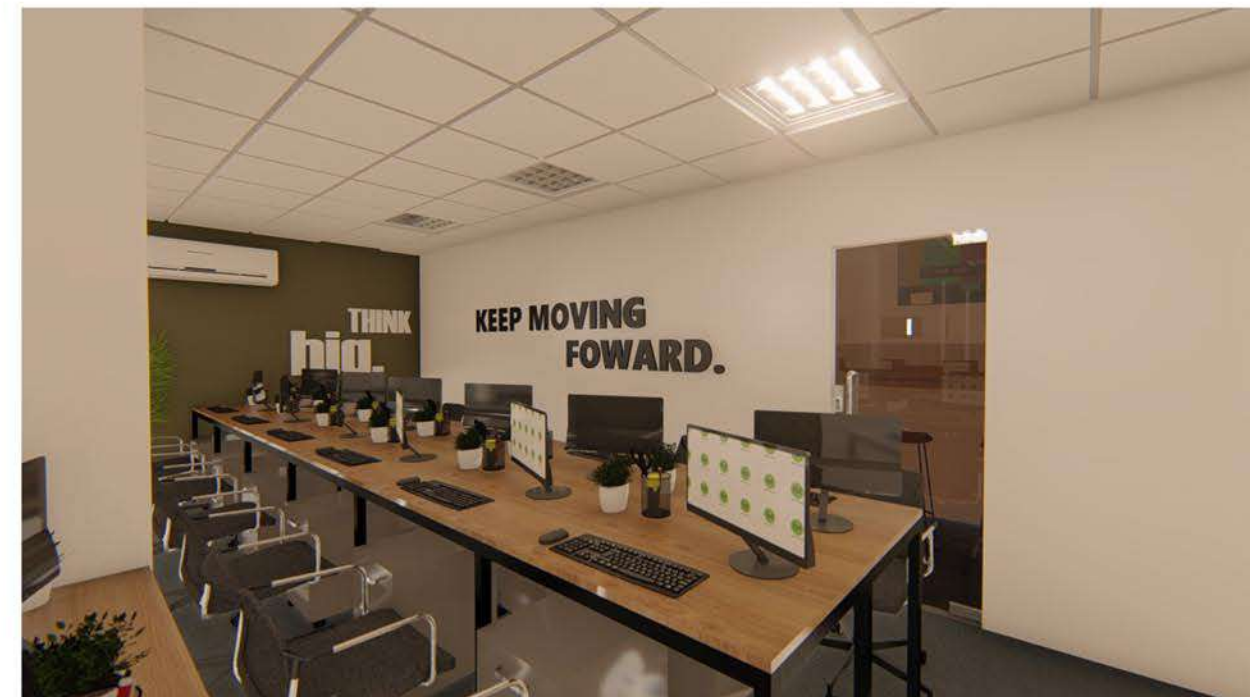

3D PERSPECTIVE (OPTION A)
SCALE: NTS

 MAGNAPATH AUSTRALIA SRI LANKA PHILIPPINES NEPAL	PROJECT:	BPO/KPO OFFICE SPACE (OPTION A) LARGE TEAM ENVIRONMENT	SHEET CONTENT:	DESIGN BY:	CADD BY:
	LOCATION:		FOURTH FLOOR PLAN	NCP	NCP
			3D PERSPECTIVE	CHECKED BY:	
				AOM	
			APPROVED BY:	DATE:	
	GMC BUILDING, JP LAUREL HIGHWAY, TANUAN CITY, PHILIPPINES 4232		GN	10/29/2019	
			SHEET NO:	REVISION:	
			SCALE: 1:100	PL05	V5